


DO NOT SCALE
IF IN DOUBT-ASK

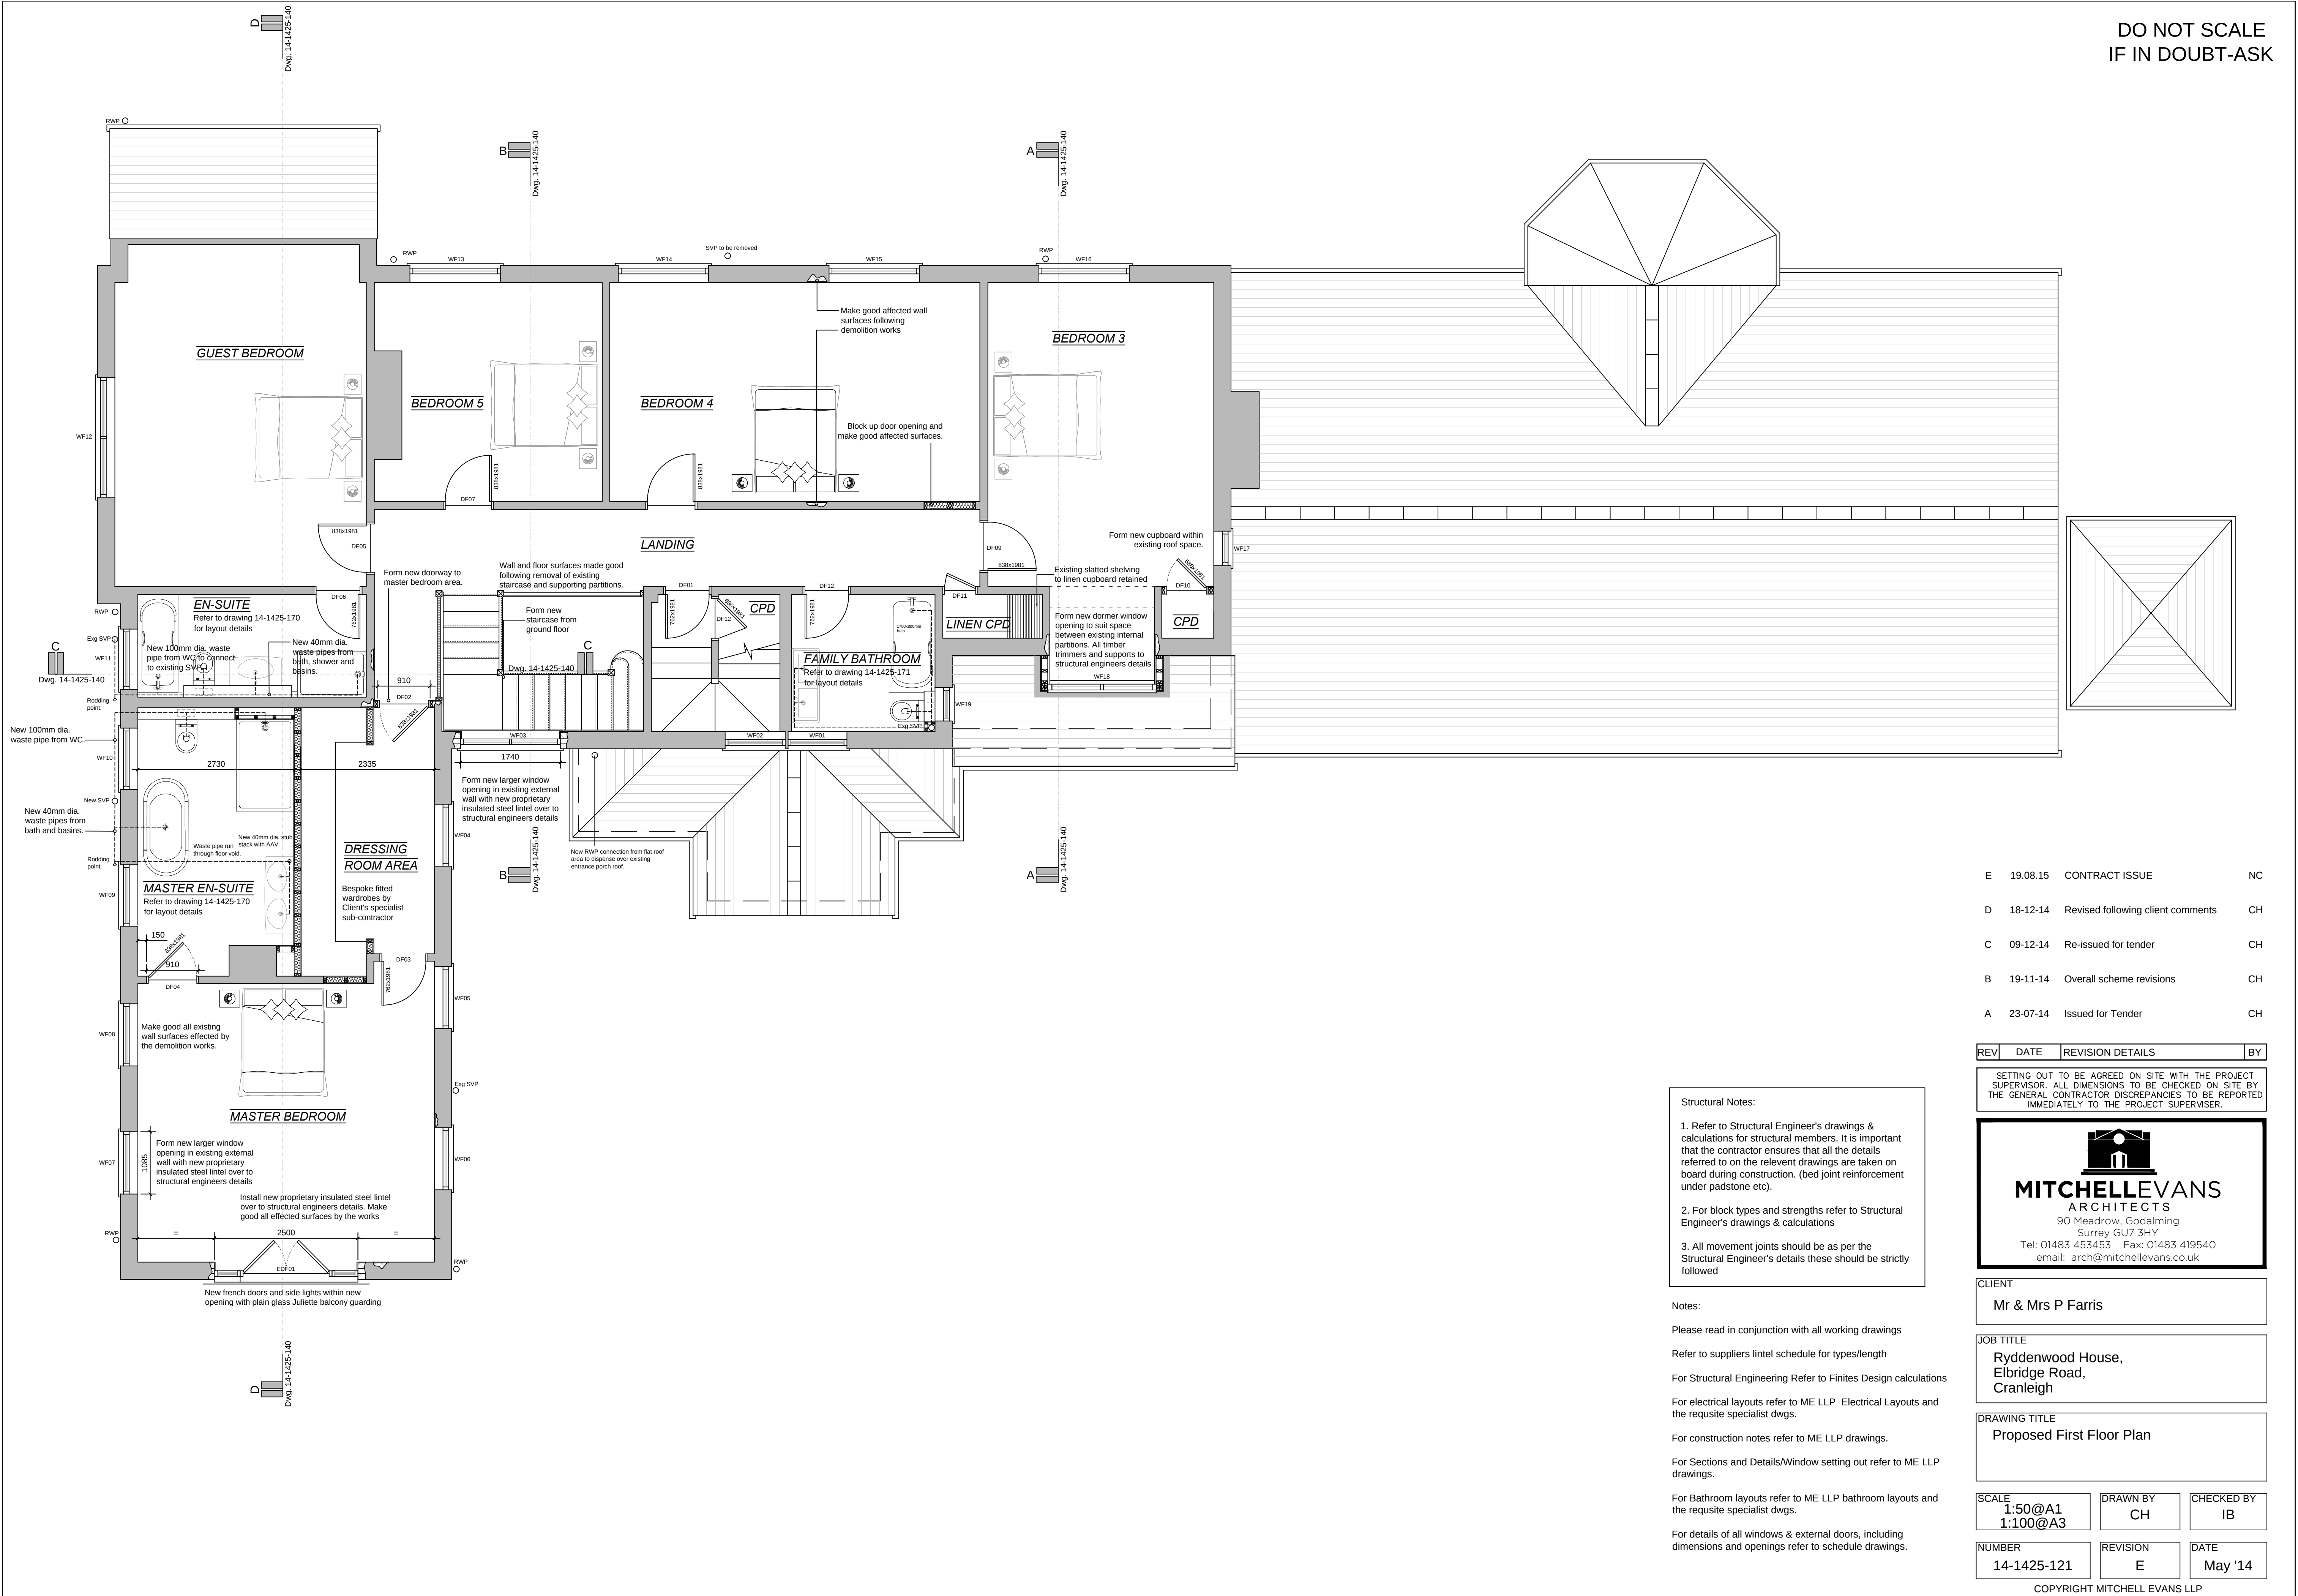

E	19.08.15	CONTRACT ISSUE	NC
D	18-12-14	Revised following client comments	CH
C	09-12-14	Re-issued for tender	CH
B	19-11-14	Overall scheme revisions	CH
A	23-07-14	Issued for Tender	CH

REV	DATE	REVISION DETAILS	BY
-----	------	------------------	----

SETTING OUT TO BE AGREED ON SITE WITH THE PROJECT SUPERVISOR. ALL DIMENSIONS TO BE CHECKED ON SITE BY THE GENERAL CONTRACTOR. DISCREPANCIES TO BE REPORTED IMMEDIATELY TO THE PROJECT SUPERVISOR.



MITCHELLEVANS
ARCHITECTS
90 Meadow, Godalming
Surrey GU7 3HY
Tel: 01483 453453 Fax: 01483 419540
email: arch@mitchellevans.co.uk

CLIENT
Mr & Mrs P Farris

JOB TITLE
Ryddenwood House,
Elbridge Road,
Cranleigh

DRAWING TITLE
Proposed First Floor Plan

SCALE 1:50@A1 1:100@A3	DRAWN BY CH	CHECKED BY IB
NUMBER 14-1425-121	REVISION E	DATE May '14

COPYRIGHT MITCHELL EVANS LLP

Structural Notes:

1. Refer to Structural Engineer's drawings & calculations for structural members. It is important that the contractor ensures that all the details referred to on the relevant drawings are taken on board during construction. (bed joint reinforcement under padstone etc).
2. For block types and strengths refer to Structural Engineer's drawings & calculations
3. All movement joints should be as per the Structural Engineer's details these should be strictly followed

Notes:

Please read in conjunction with all working drawings

Refer to suppliers lintel schedule for types/length

For Structural Engineering Refer to Finites Design calculations

For electrical layouts refer to ME LLP Electrical Layouts and the requisite specialist dwgs.

For construction notes refer to ME LLP drawings.

For Sections and Details/Window setting out refer to ME LLP drawings.

For Bathroom layouts refer to ME LLP bathroom layouts and the requisite specialist dwgs.

For details of all windows & external doors, including dimensions and openings refer to schedule drawings.